

โครงการงานปรับปรุงระบบสุขภาพิบาล

อาคารคณะเทคโนโลยีสารสนเทศและการสื่อสาร
มหาวิทยาลัยมหิดล ศาลายา




Content

Page	Description
1	Content
2	Zone A 1,2,3 New Layout
3	Zone A 1,2,3 Key Plan
4	Zone A 1,2,3 Dimension
5	Zone A 1,2,3 Floor Plan
6	Zone B 1,2,3 New Layout
7	Zone B 1,2,3 Key Plan
8	Zone B 1,2,3 Dimension
9	Zone B 1,2,3 Floor Plan



Zone A- 1/2/3

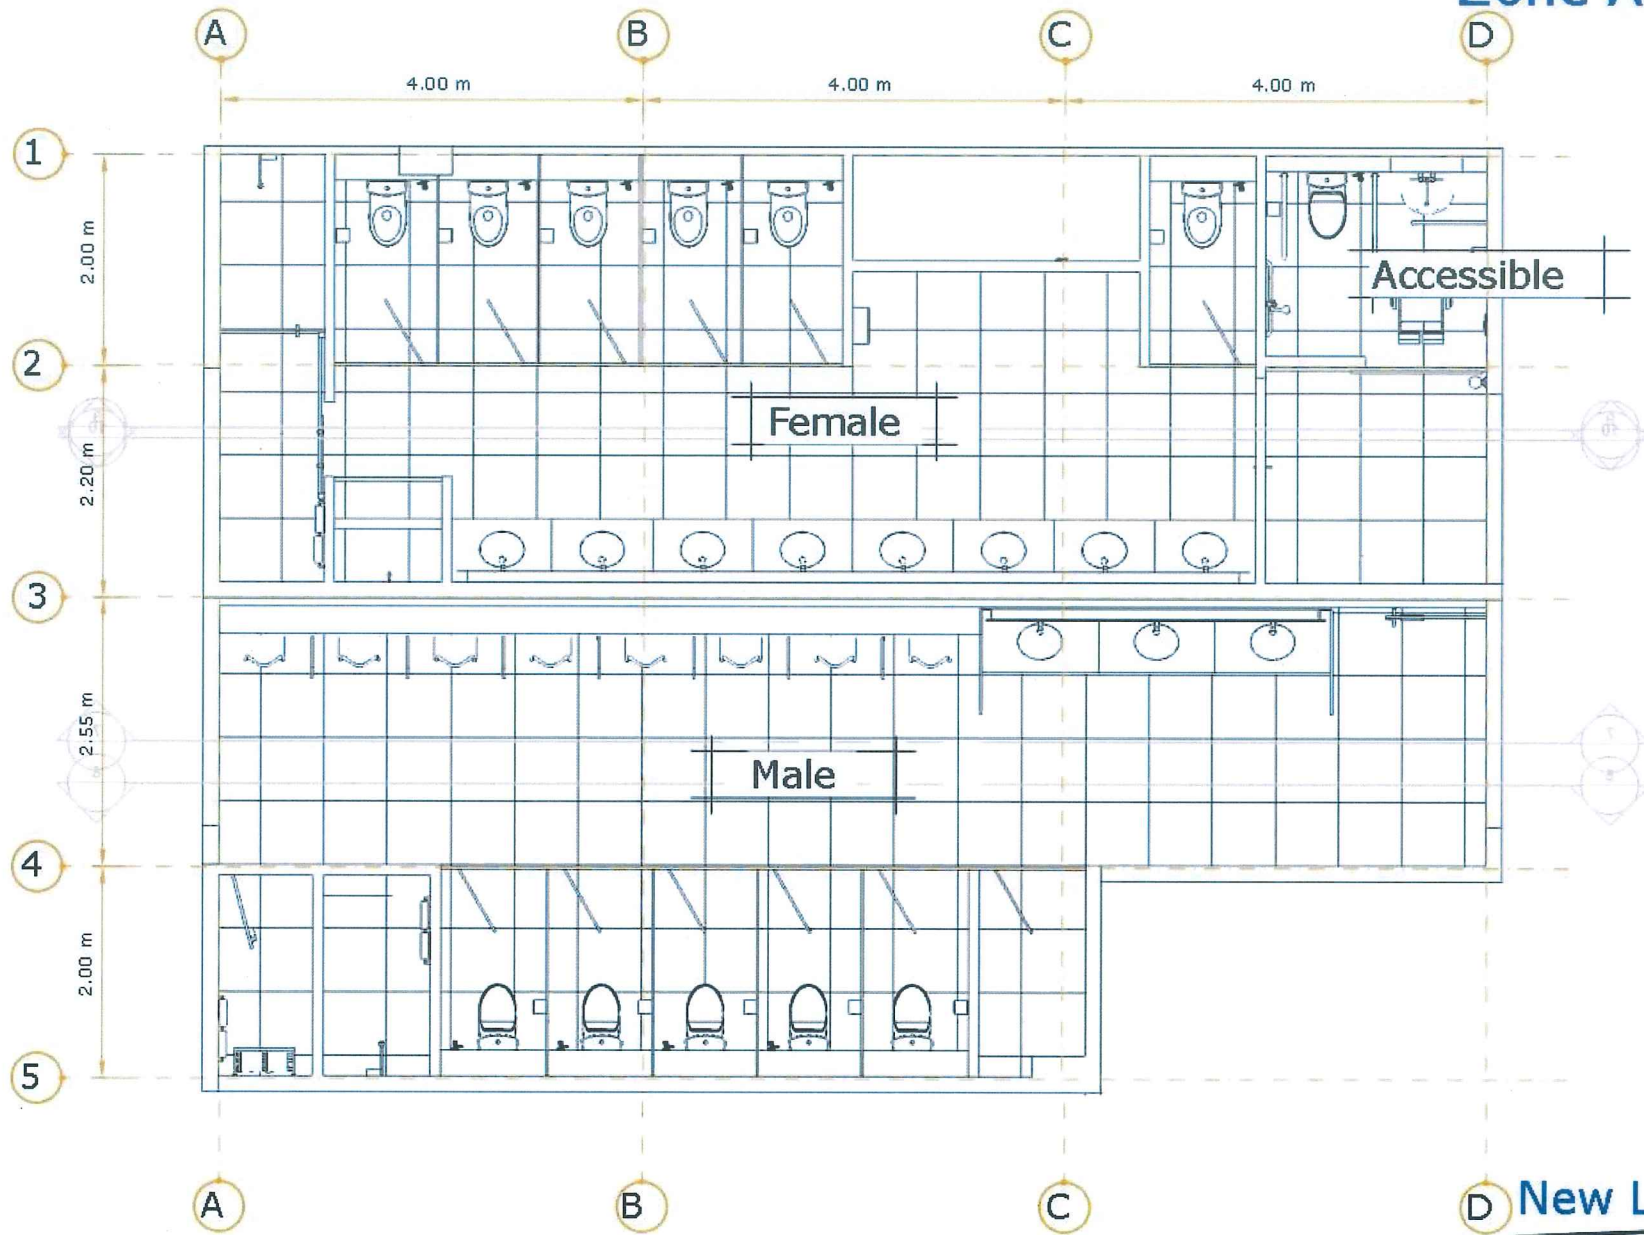


New Layout

Scale 1: 50

Archi-tekstura arnis ICT 5manajemen



Zone A- 1/2/3

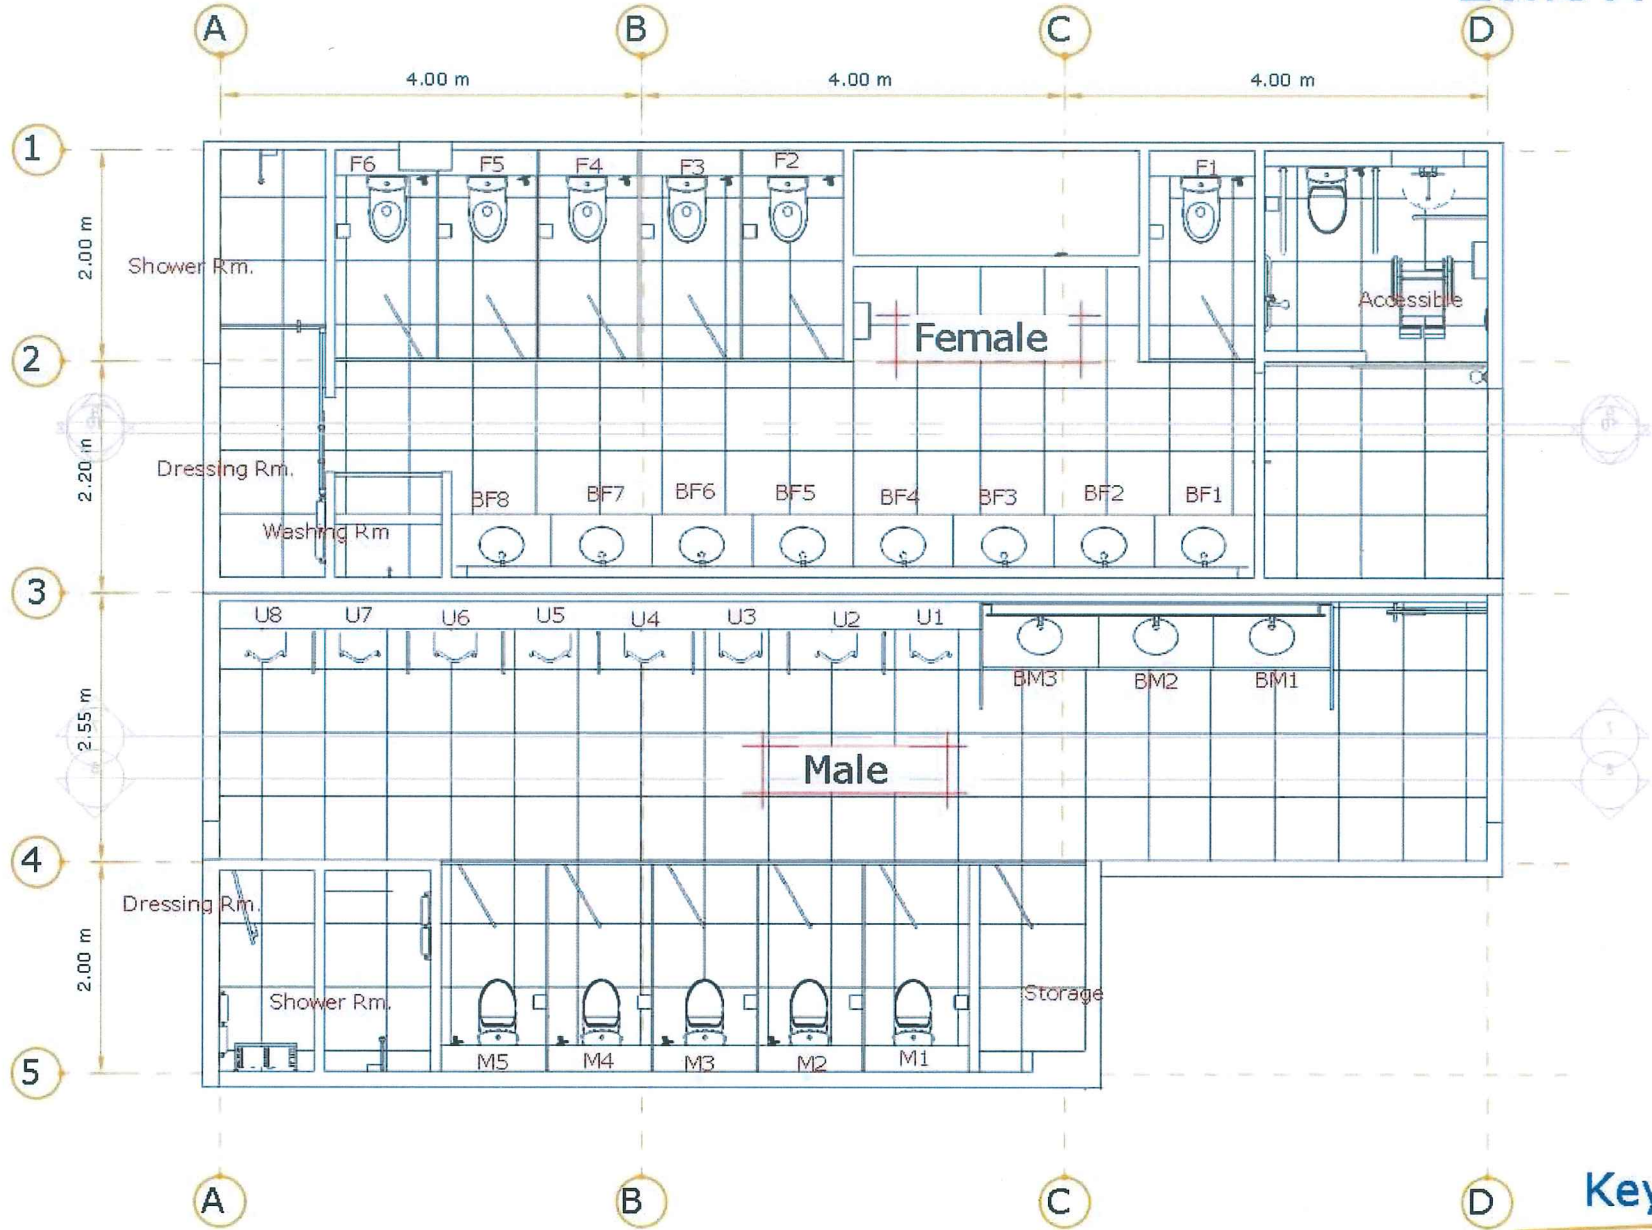


Key Plan

Scale 1: 50

กรมส่งเสริมการค้าระหว่างประเทศ กระทรวงพาณิชย์



Zone A- 1/2/3

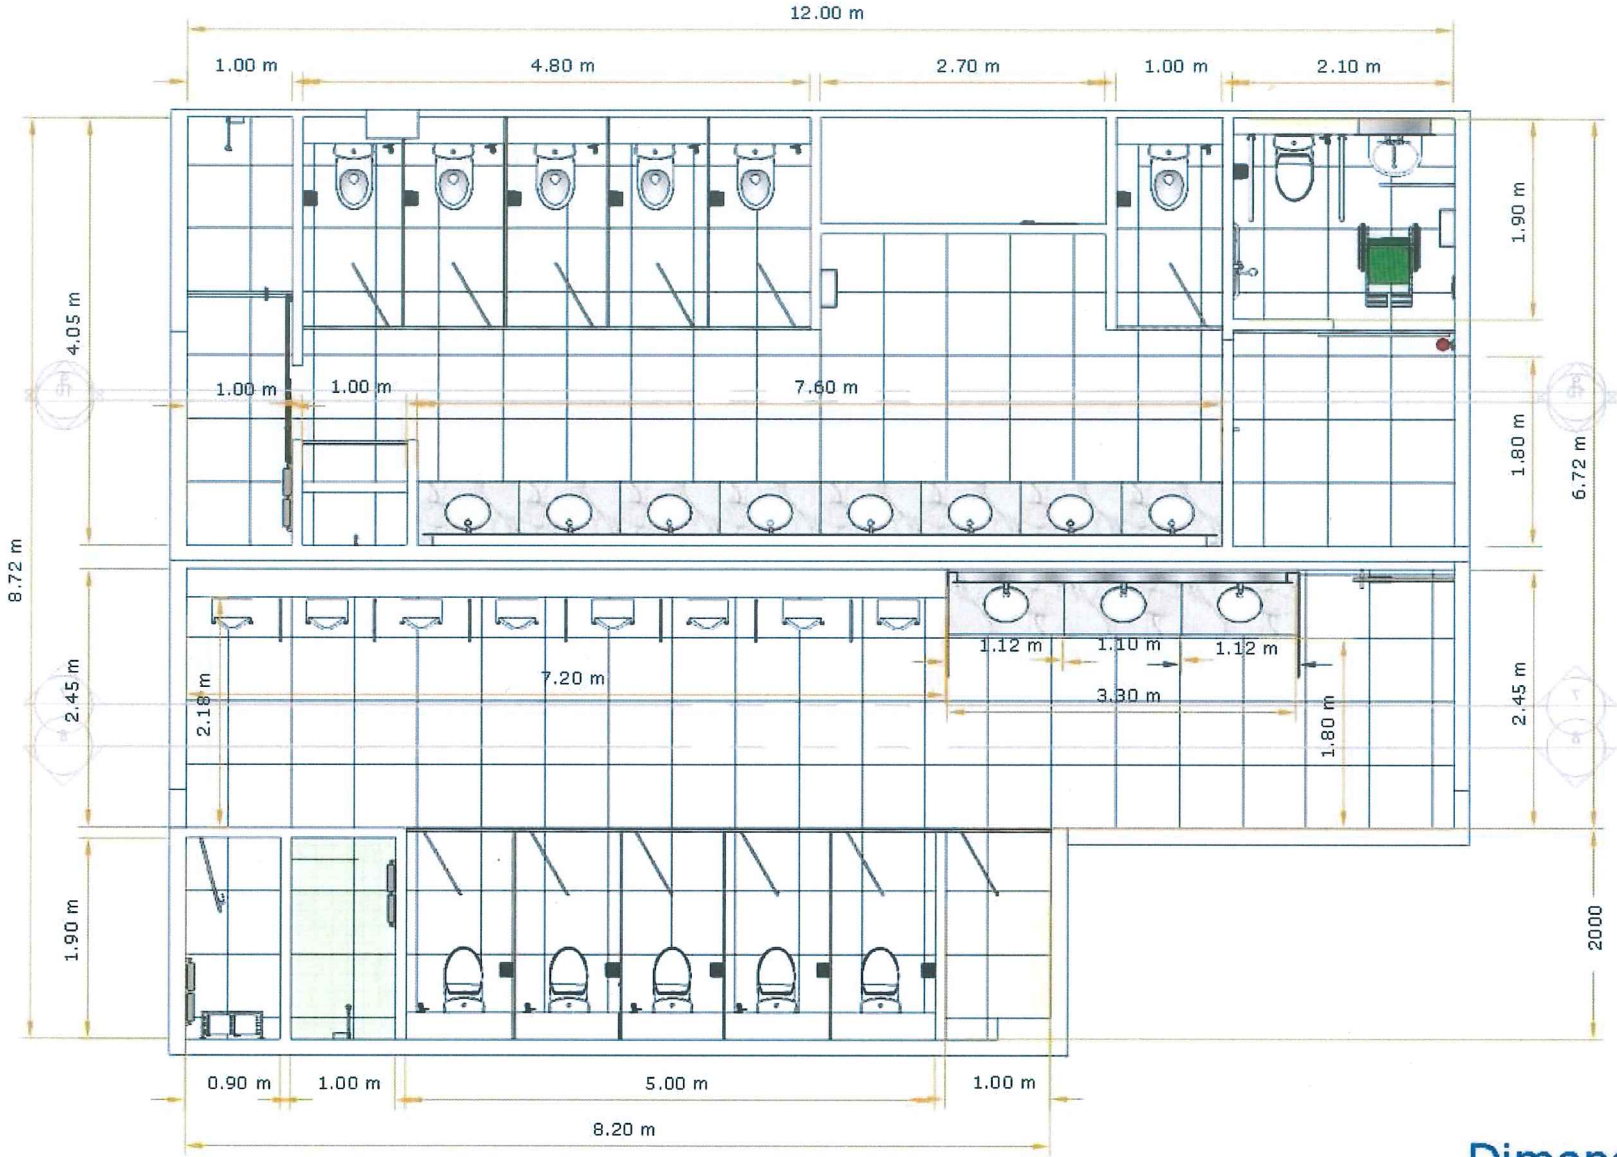


Dimension

Scale 1: 50

ក្រសួងរៀនសូត្រ និង បច្ចេកវិទ្យា ព័ត៌មាន ICT កម្ពុជា



Zone A- 1/2/3

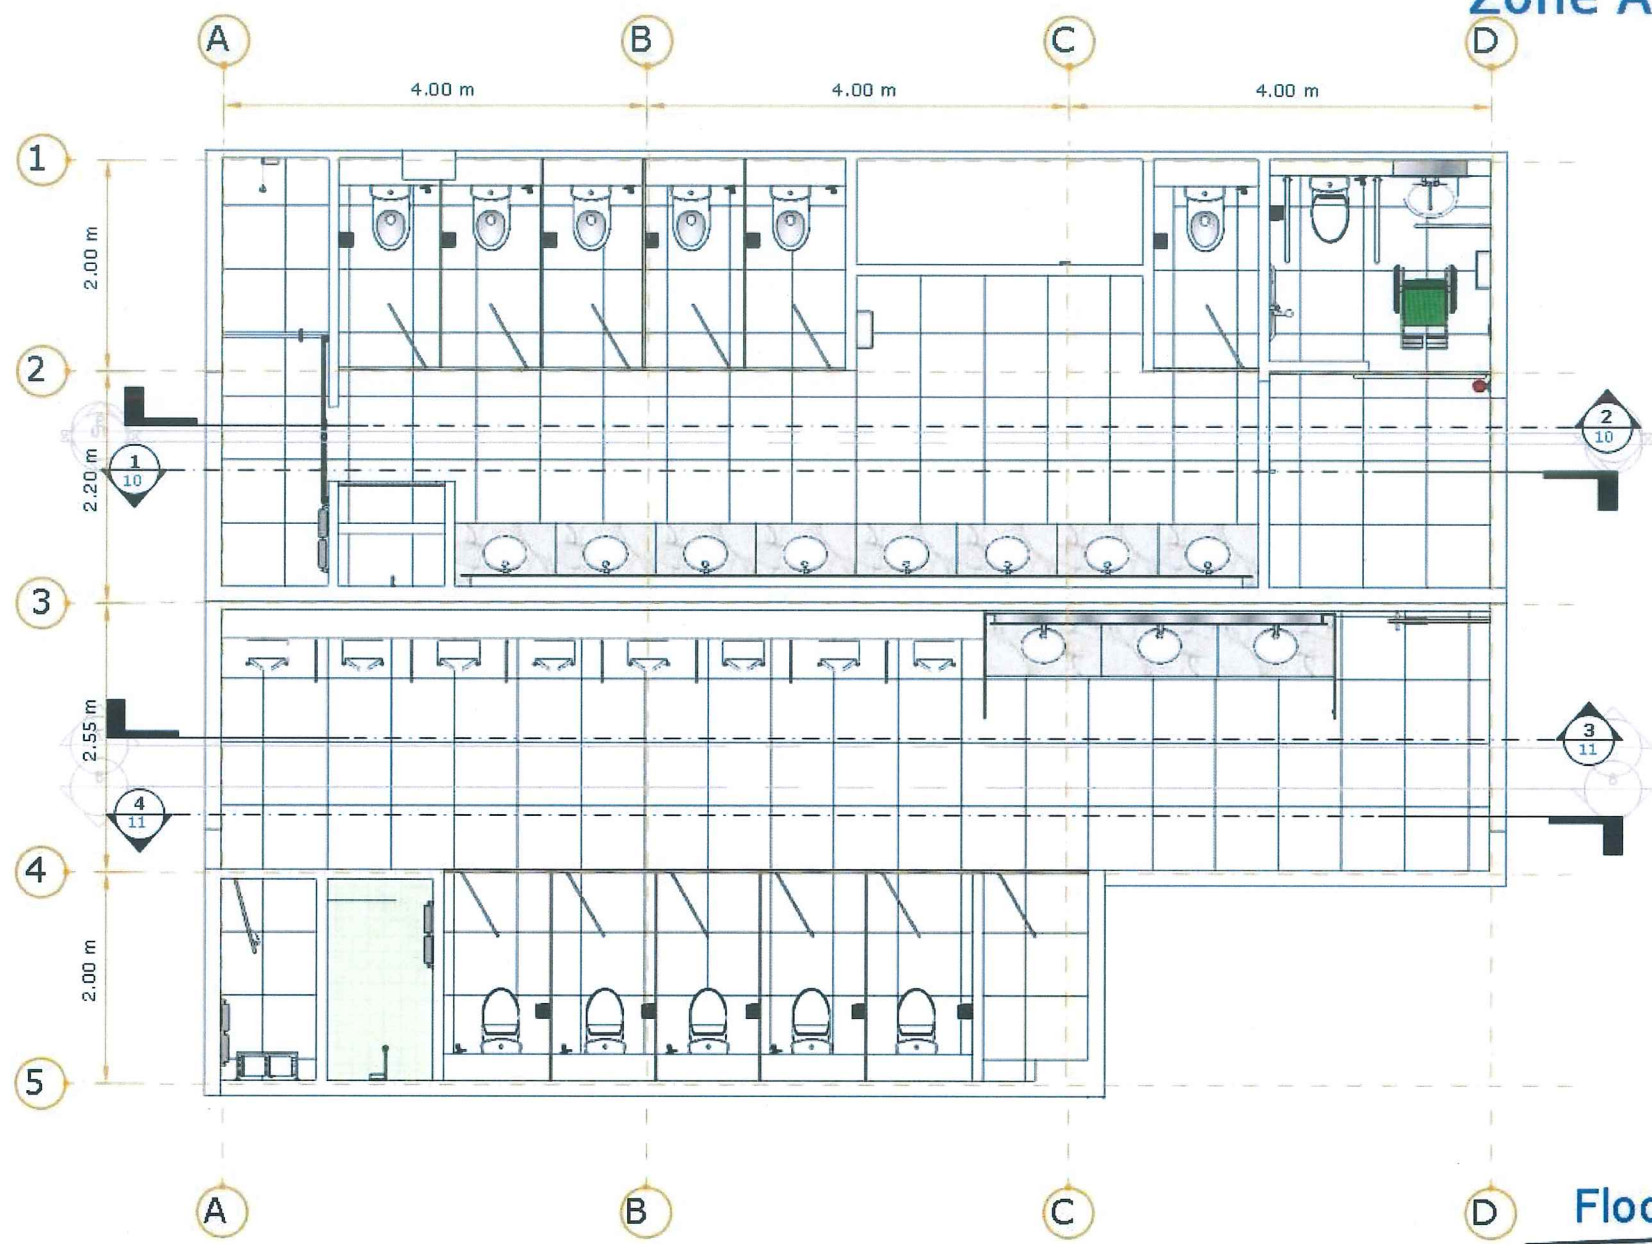


Floor Plan

Scale 1: 50

အမှတ်အသားအရပ်ရပ် ICT အသုံးပြုရန်



Zone B- 1/2/3

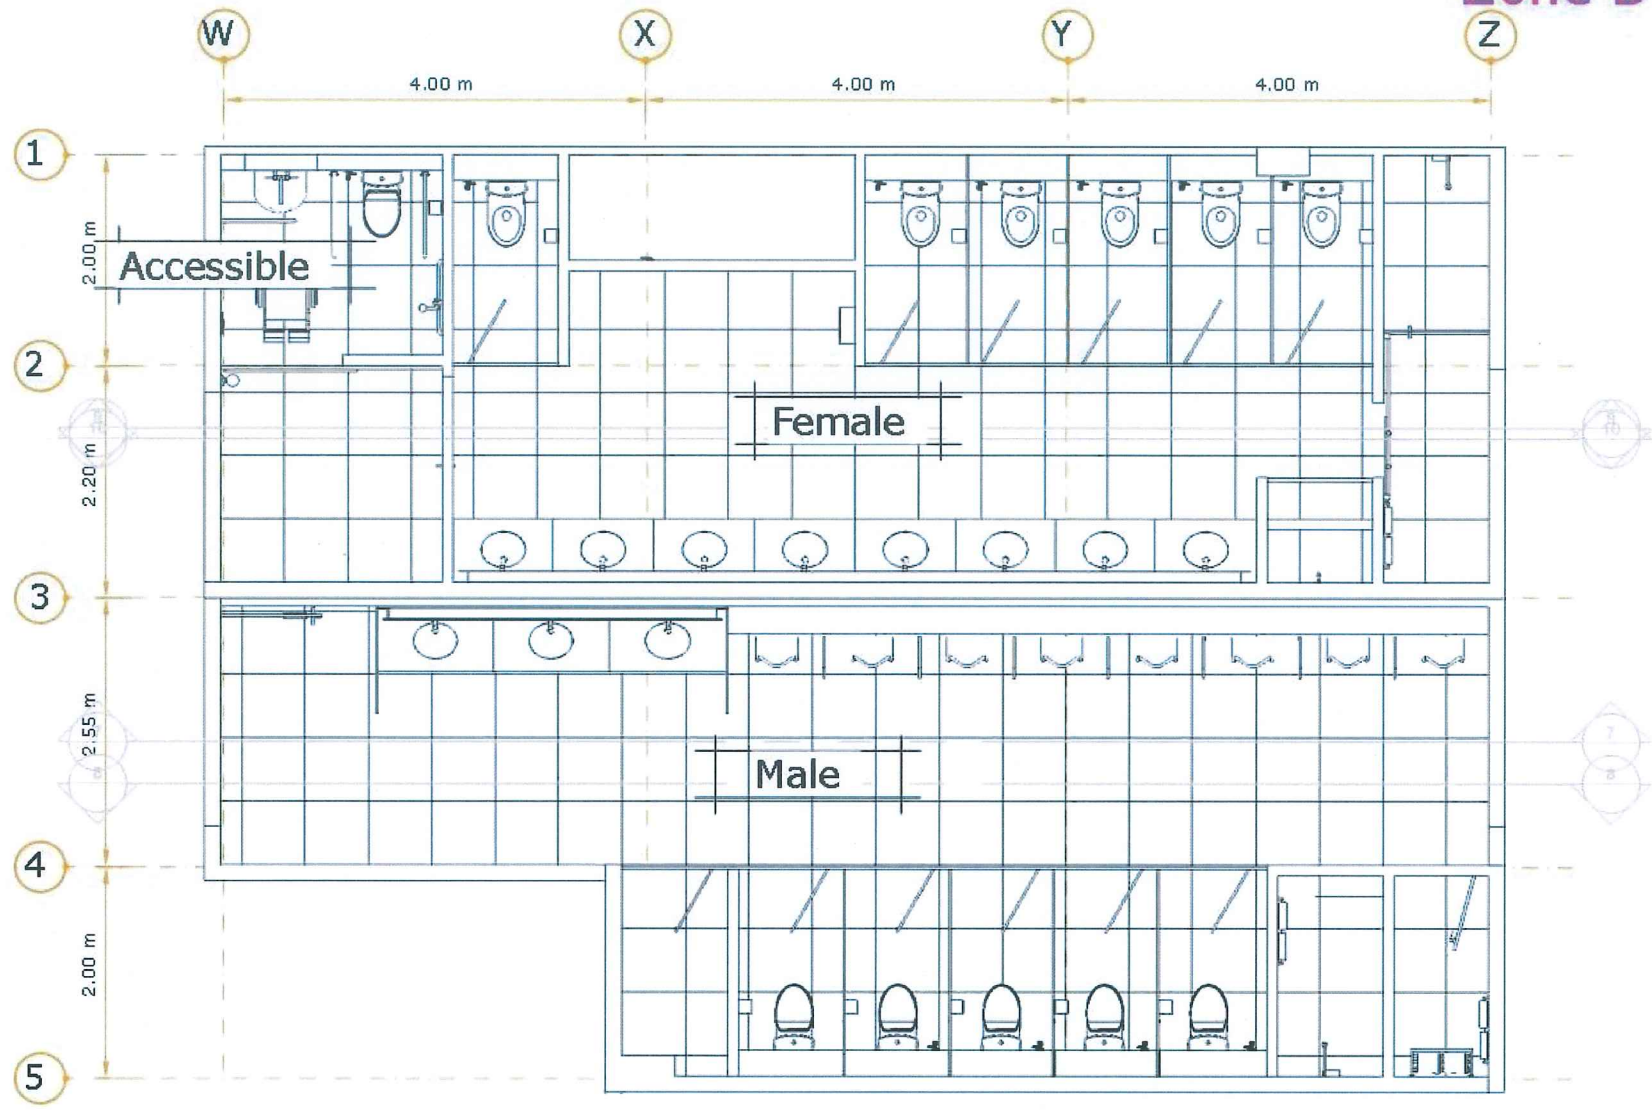


New Layout

Scale 1: 50

အိမ်ရာနှင့်အခြေခံအဆောက်အအုံများအတွက် ICT အကူအညီ



Zone B- 1/2/3

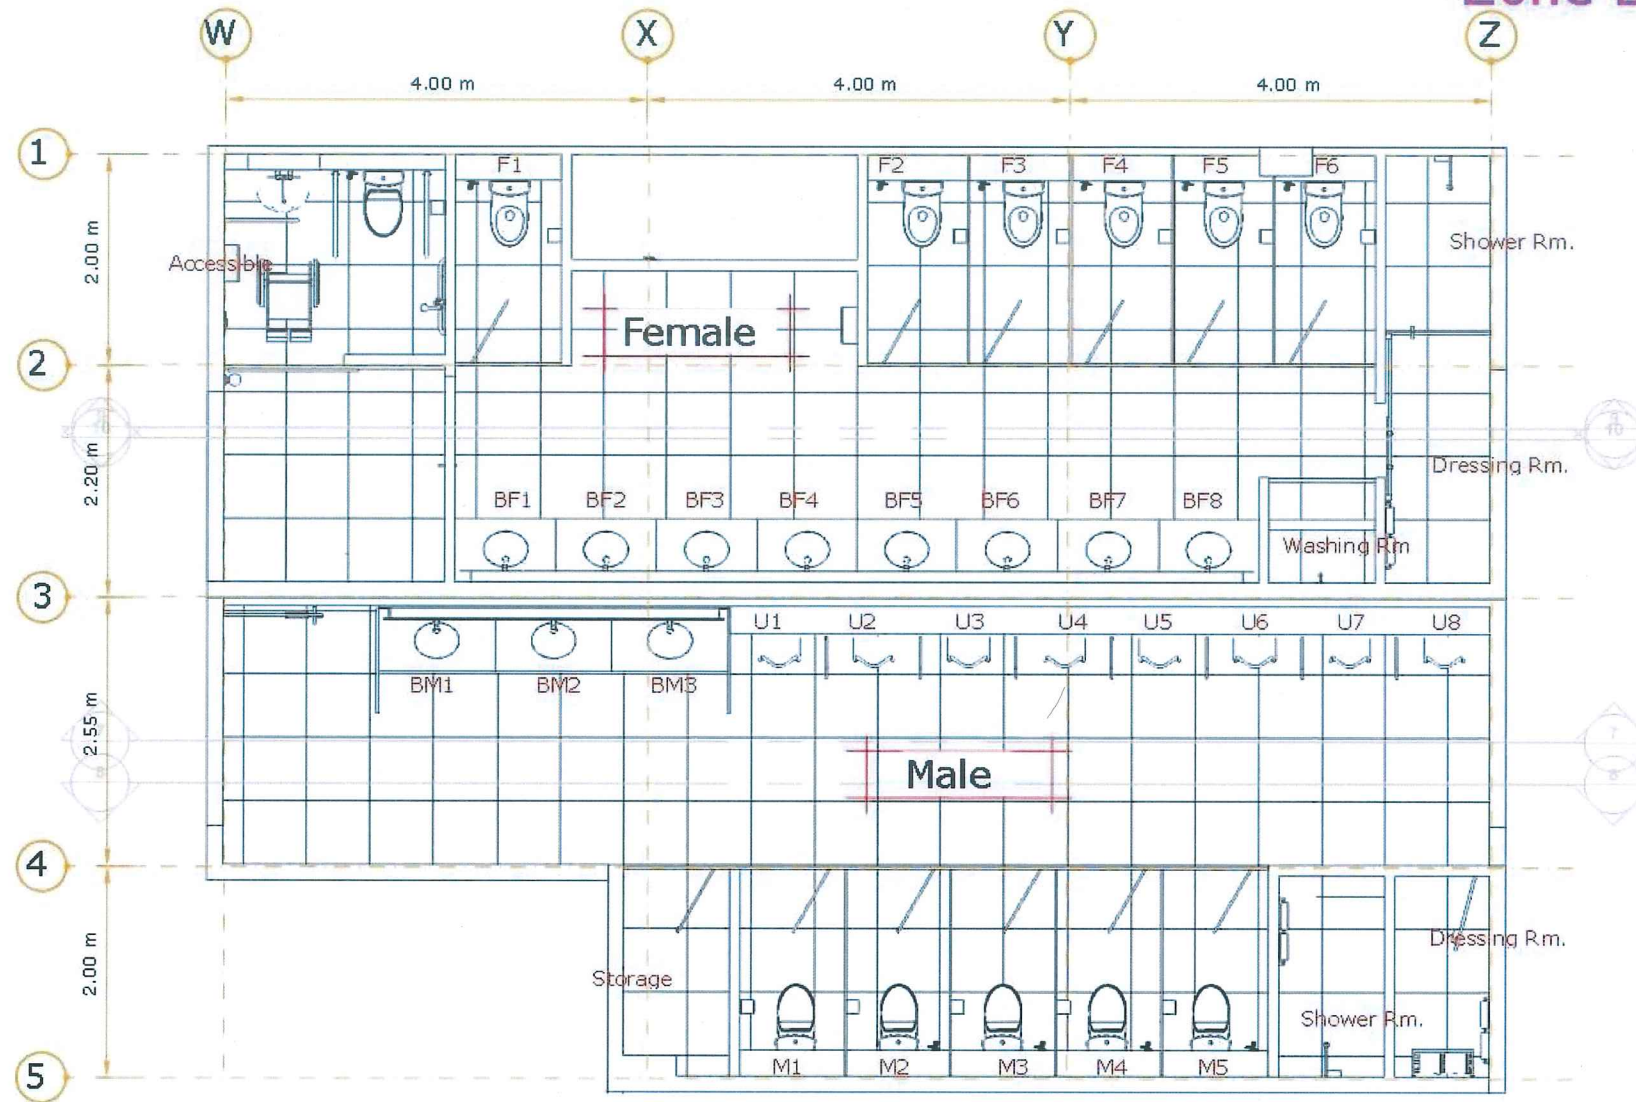


Key Plan

Scale 1: 50

အခြေခံအုတ်မြစ်အား အခြေခံ ICT အခြေခံအုတ်မြစ်



Zone B- 1/2/3

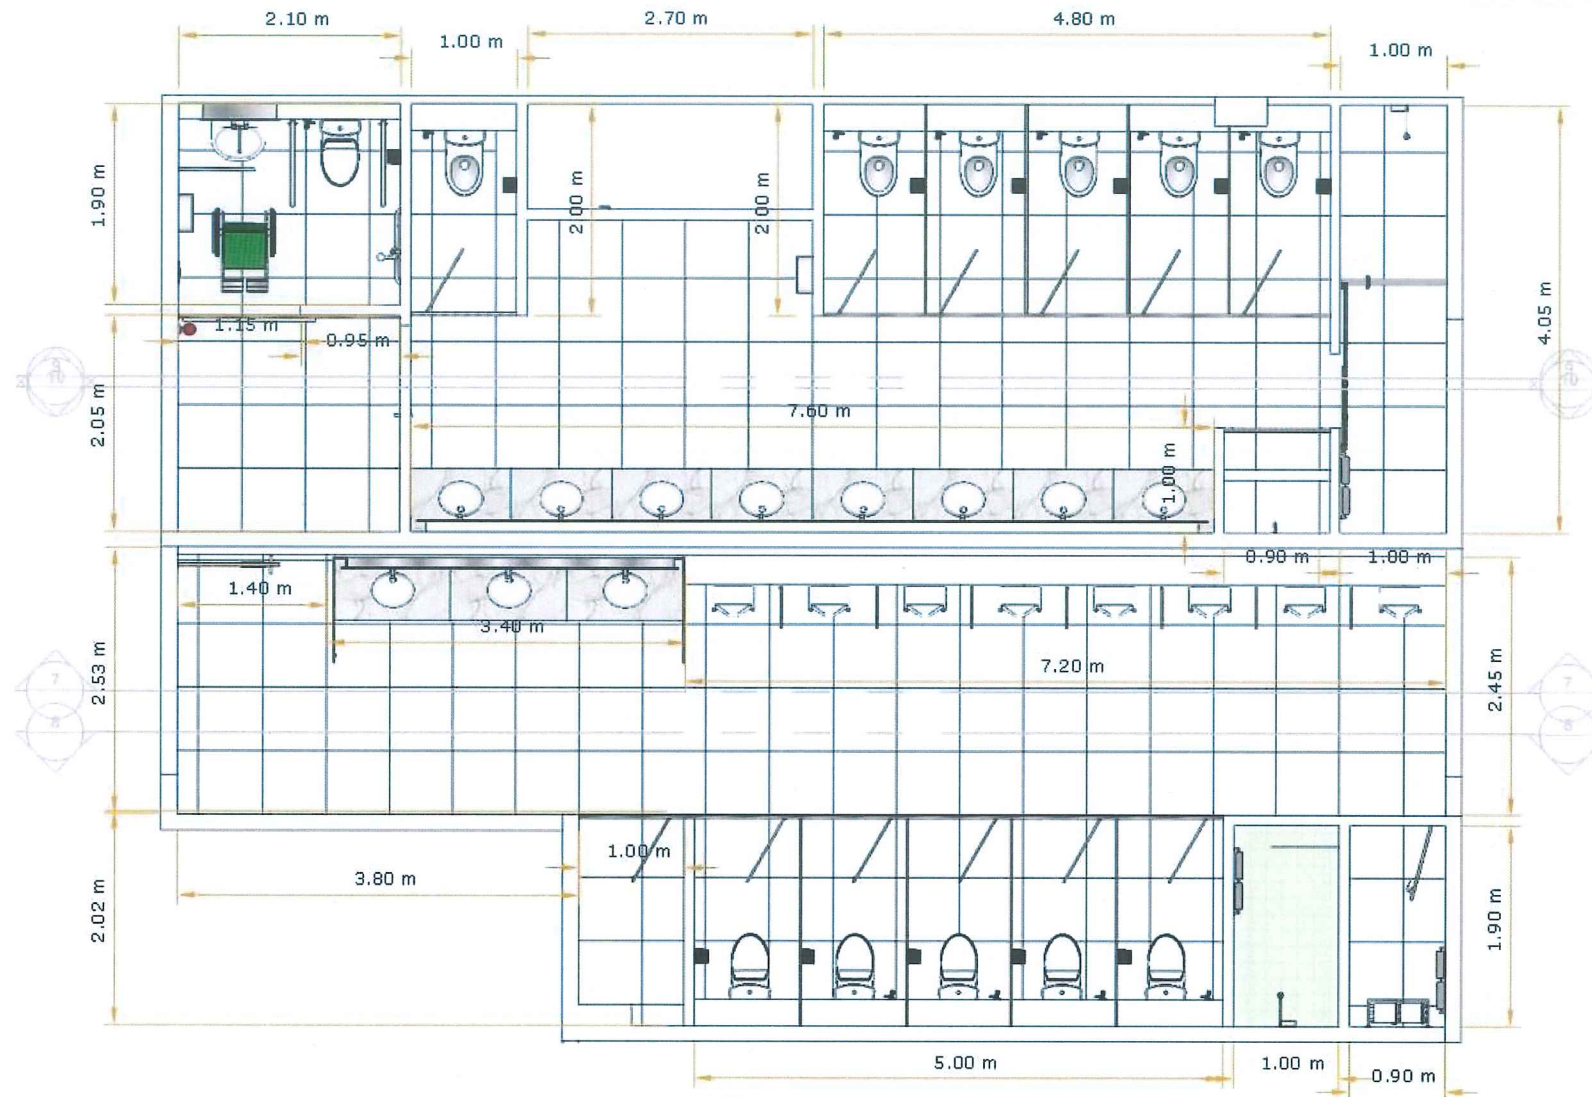


Dimension

Scale 1: 50



Zone B- 1/2/3

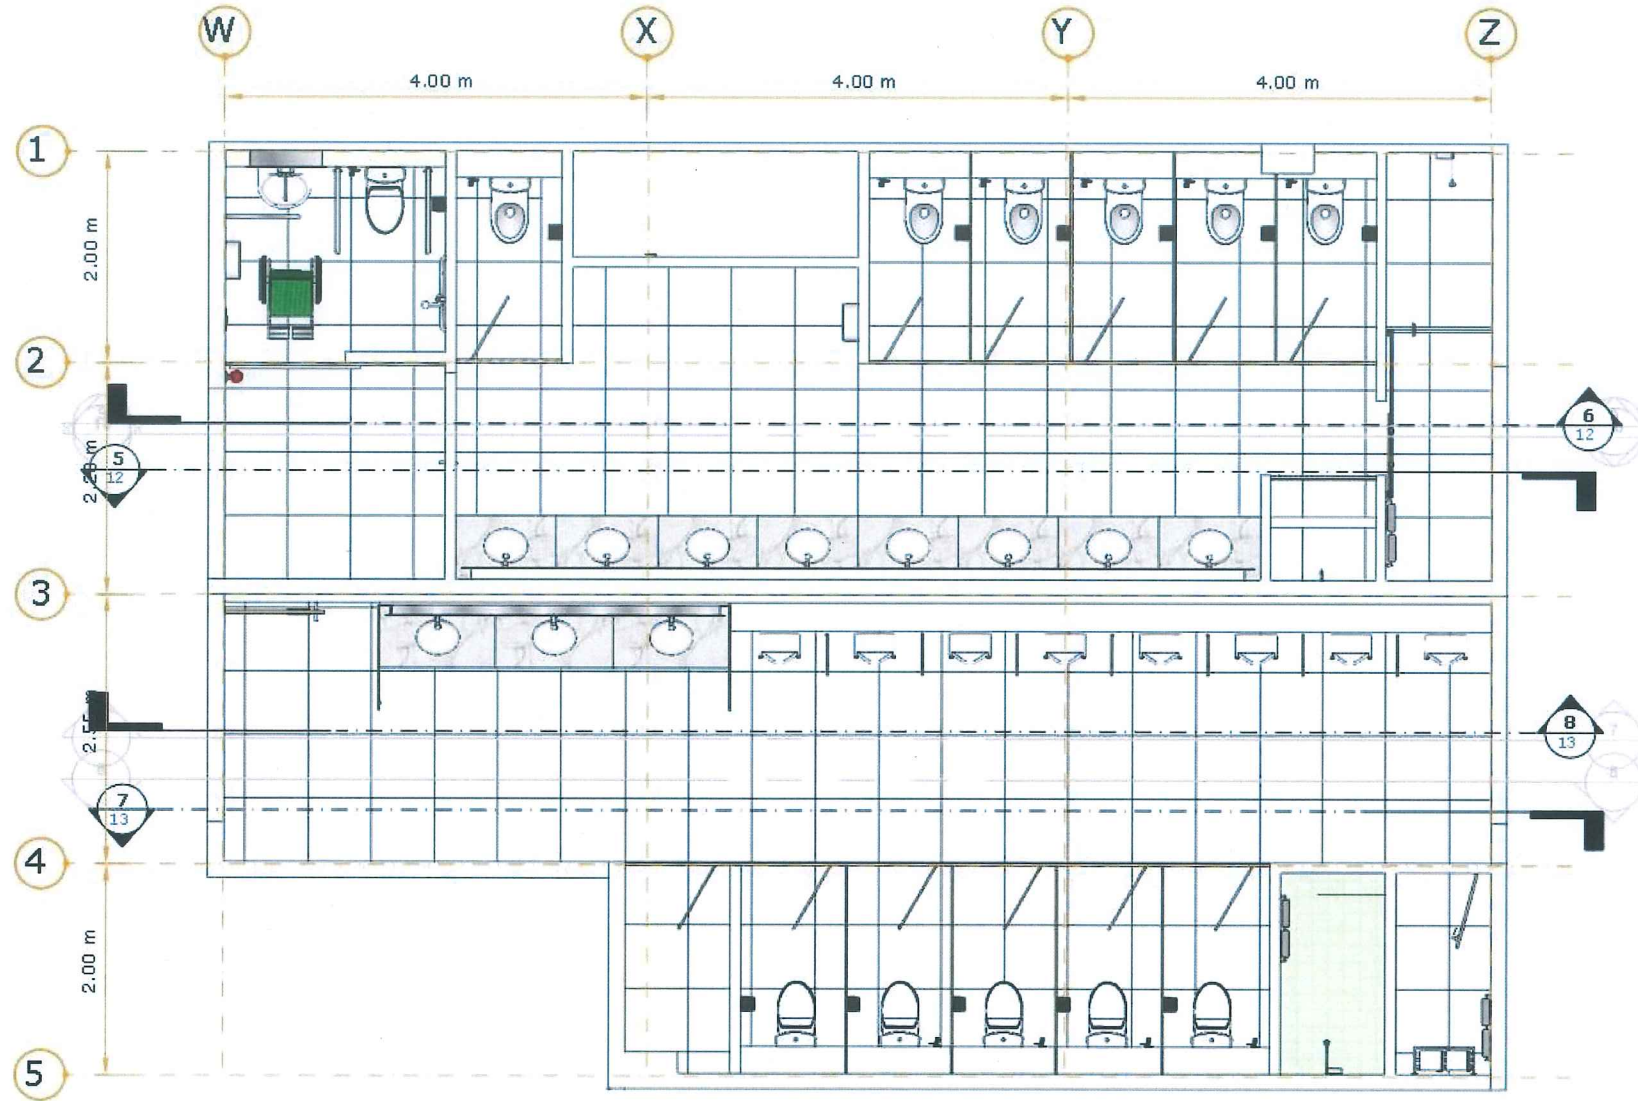


Floor Plan

Scale 1: 50


โครงการพัฒนาระบบสุขาภิบาลเมือง (ICT) กรุงเทพมหานคร



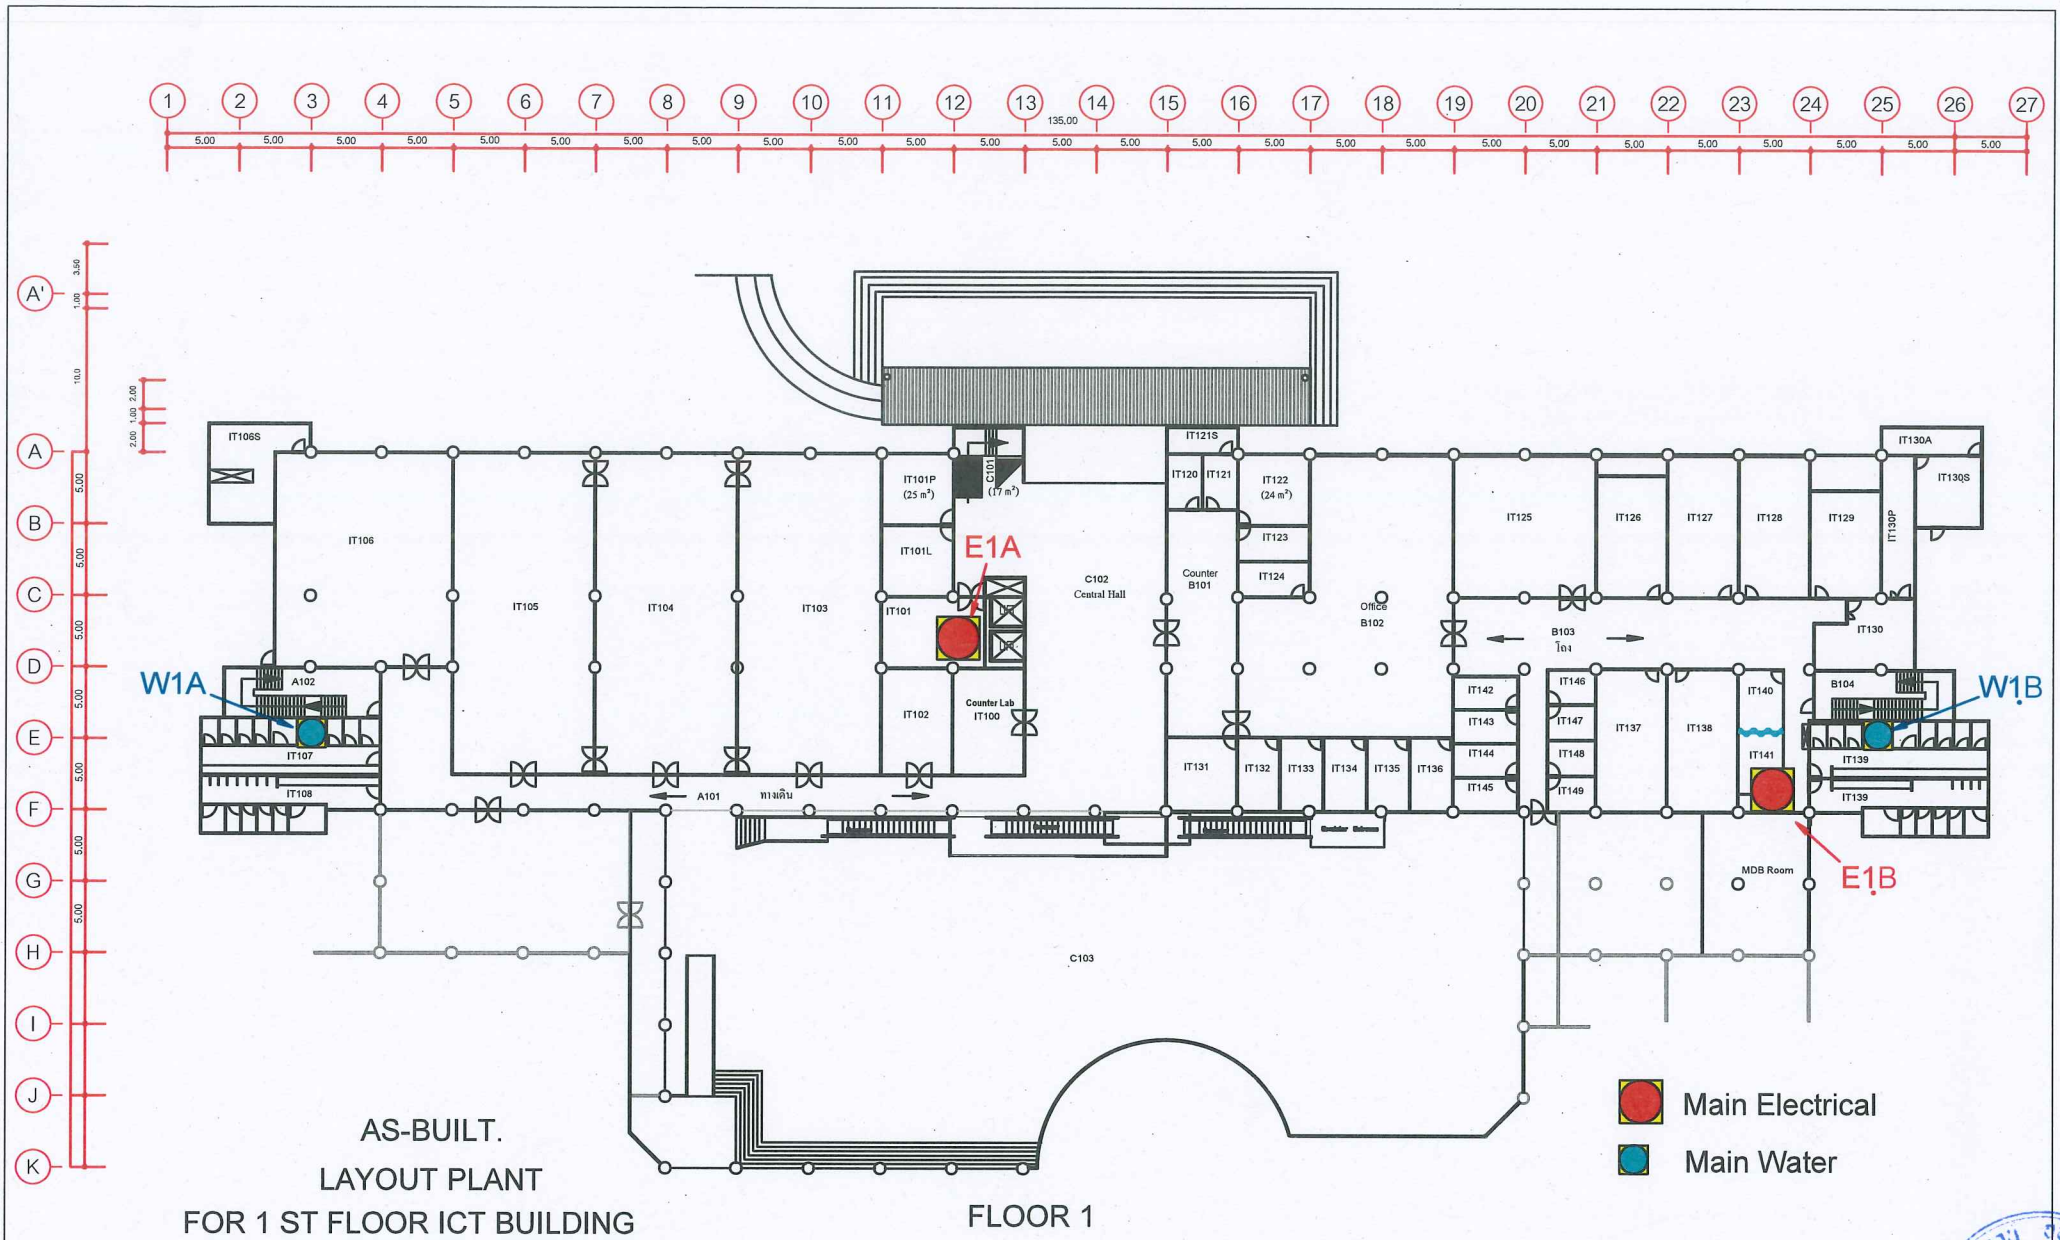

Information and communication Technology Faculty, Mahidol	Title of project	name of drawing	scale	ELENGINEER	date of revision	no.
	PROPOSE INTERIOR DESIGN & RENOVATION TO ICT CENTER MAHIDOL UNIVERSITY	AS-BUILT. LAYOUT PLANT FOR 1st FLOOR	1 / 200	Y. Jeansamoot ENGINEER ICT BUILDING	Update 24/10/2018	



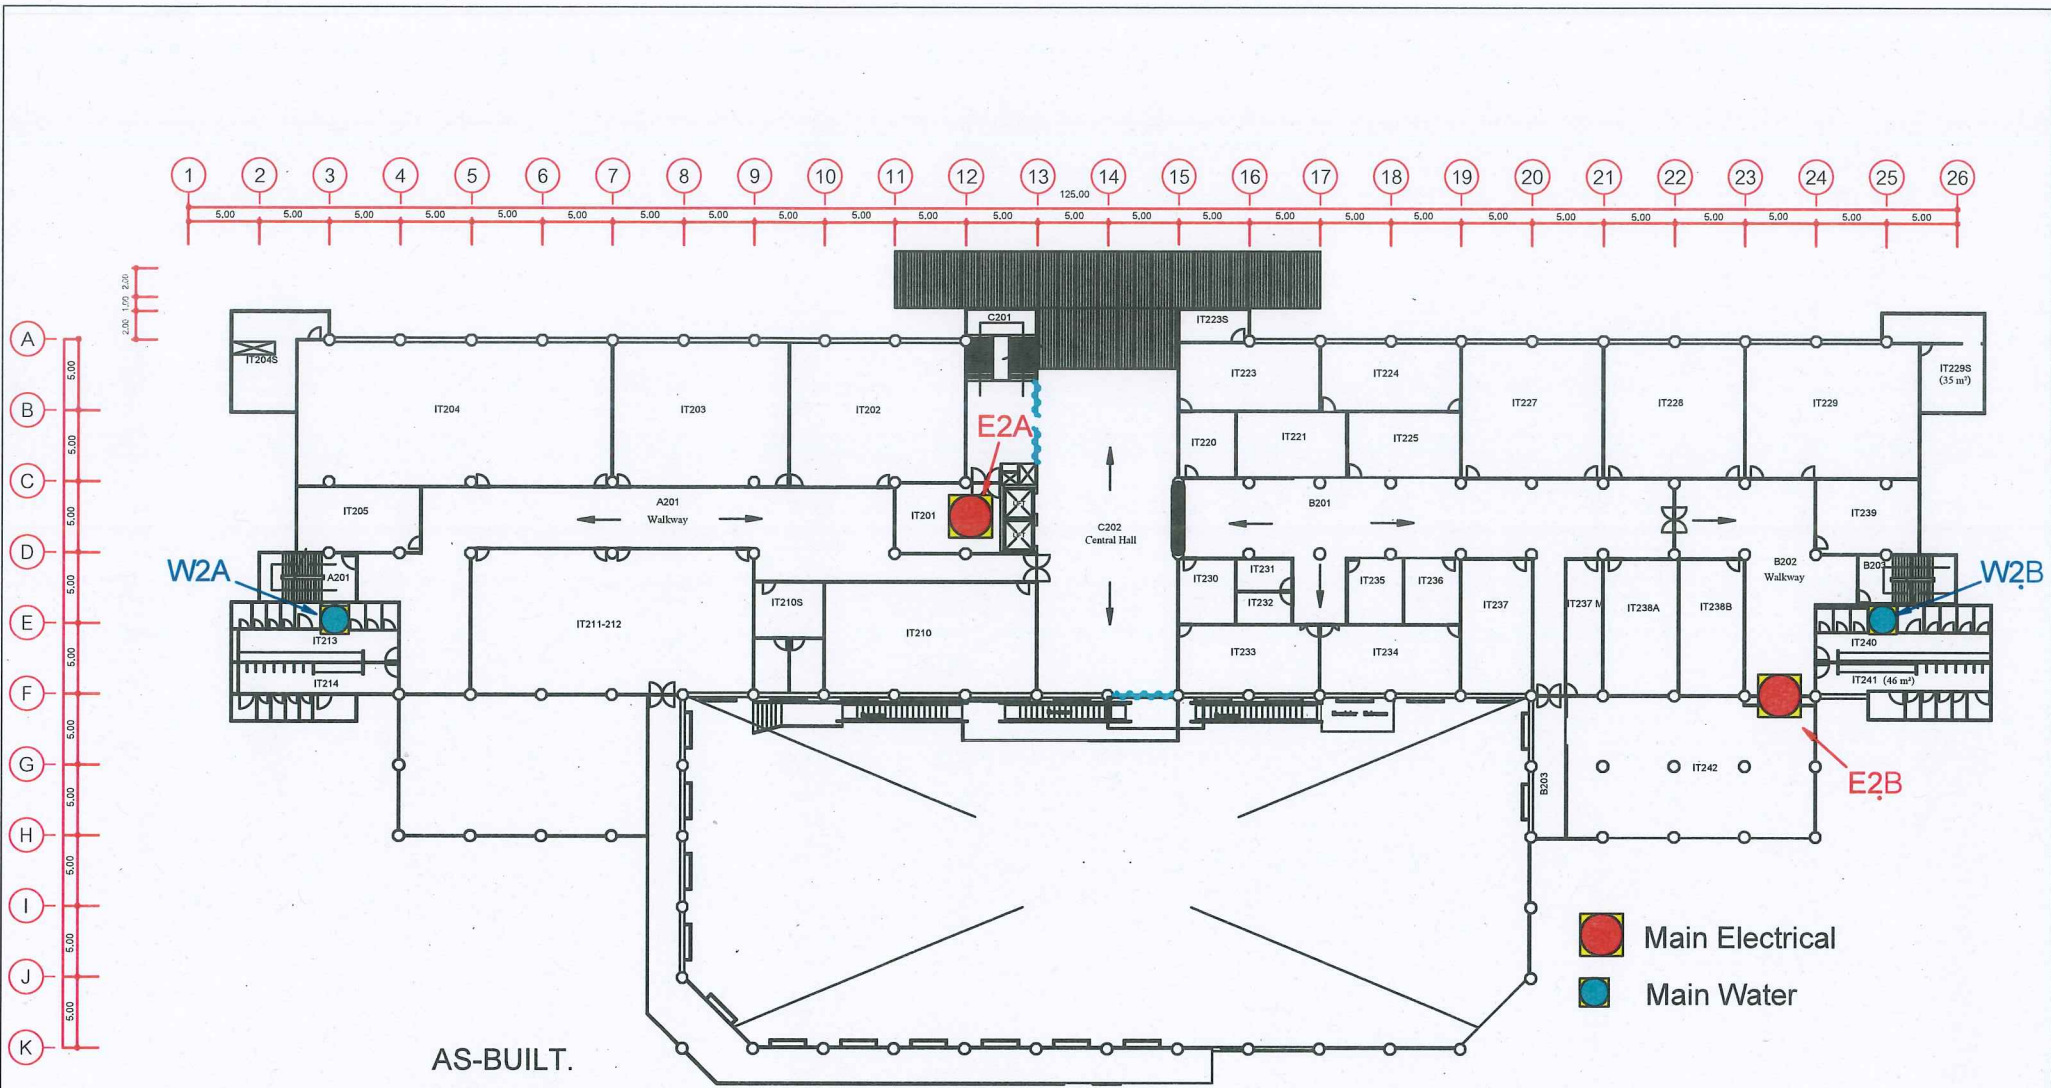


AS-BUILT.
LAYOUT PLANT
FOR 2 ND FLOOR ICT BUILDING

FLOOR 2

- Main Electrical
- Main Water

Information and Communication Technology Faculty, Mahidol University	title of project PROPOSE INTERIOR DESIGN & RENOVATION TO ICT CENTER MAHIDOL UNIVERSITY	name of drawing AS-BUILT. LAYOUT PLANT FOR 2nd FLOOR	scale 1 / 200	ELENGINEER Y. Jeansamoot ENGINEER ICT BUILDING	date of revision Update Sep.29,2020	no. 2
---	--	---	------------------	---	--	----------




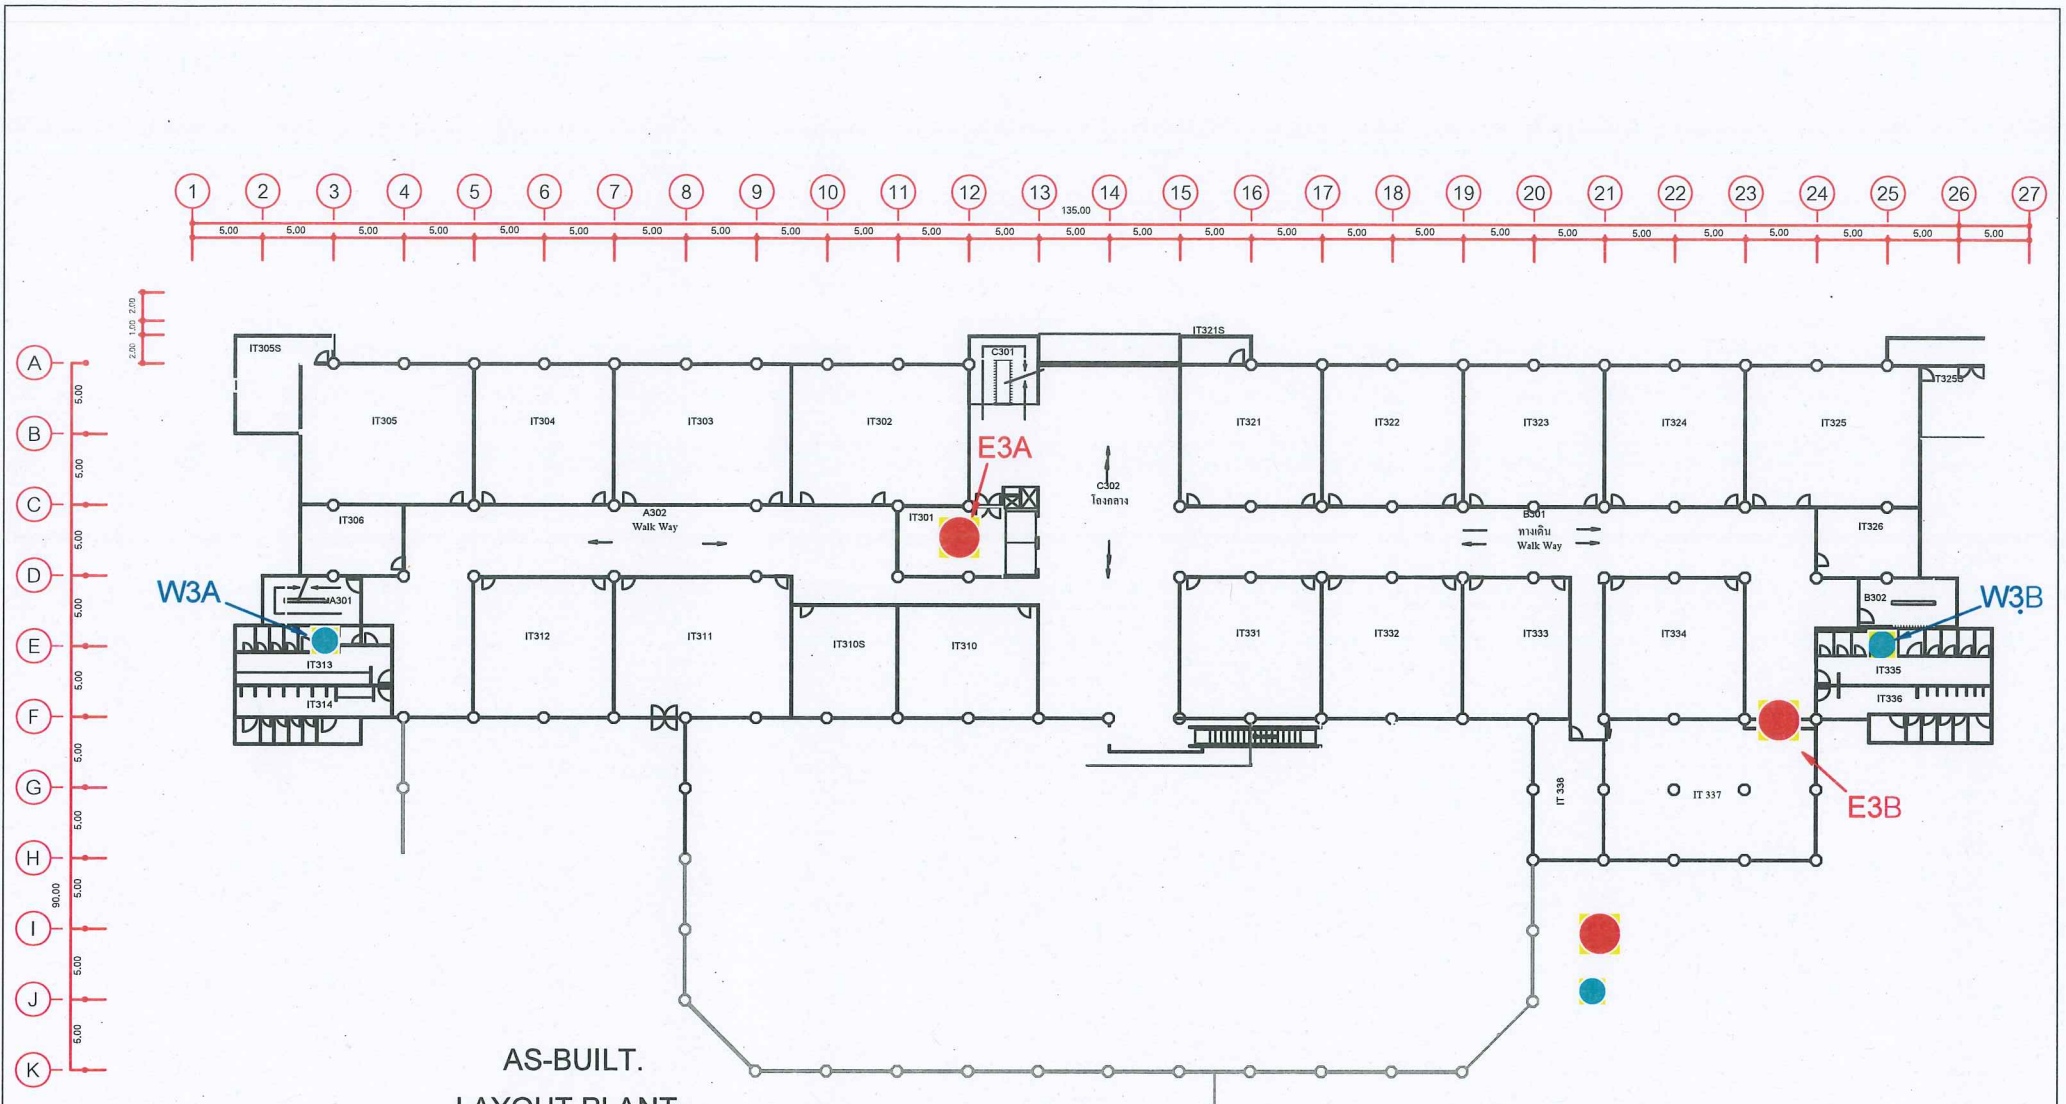

AS-BUILT.
LAYOUT PLAN
FOR 3 RD FLOOR ICT BUILDING
FLOOR 3

Information and Communication Technology Faculty, Mahidol University	Title of project	name of drawing	scale	ELENGINEER	date of revision	no.
	PROPOSE INTERIOR DESIGN & RENOVATION TO ICT CENTER MAHIDOL UNIVERSITY	AS-BUILT. LAYOUT PLAN FOR 3rd FLOOR	1/200	Y.Jeansamoot ENGINEER ICT BUILDING	Update 14/02/2019	3



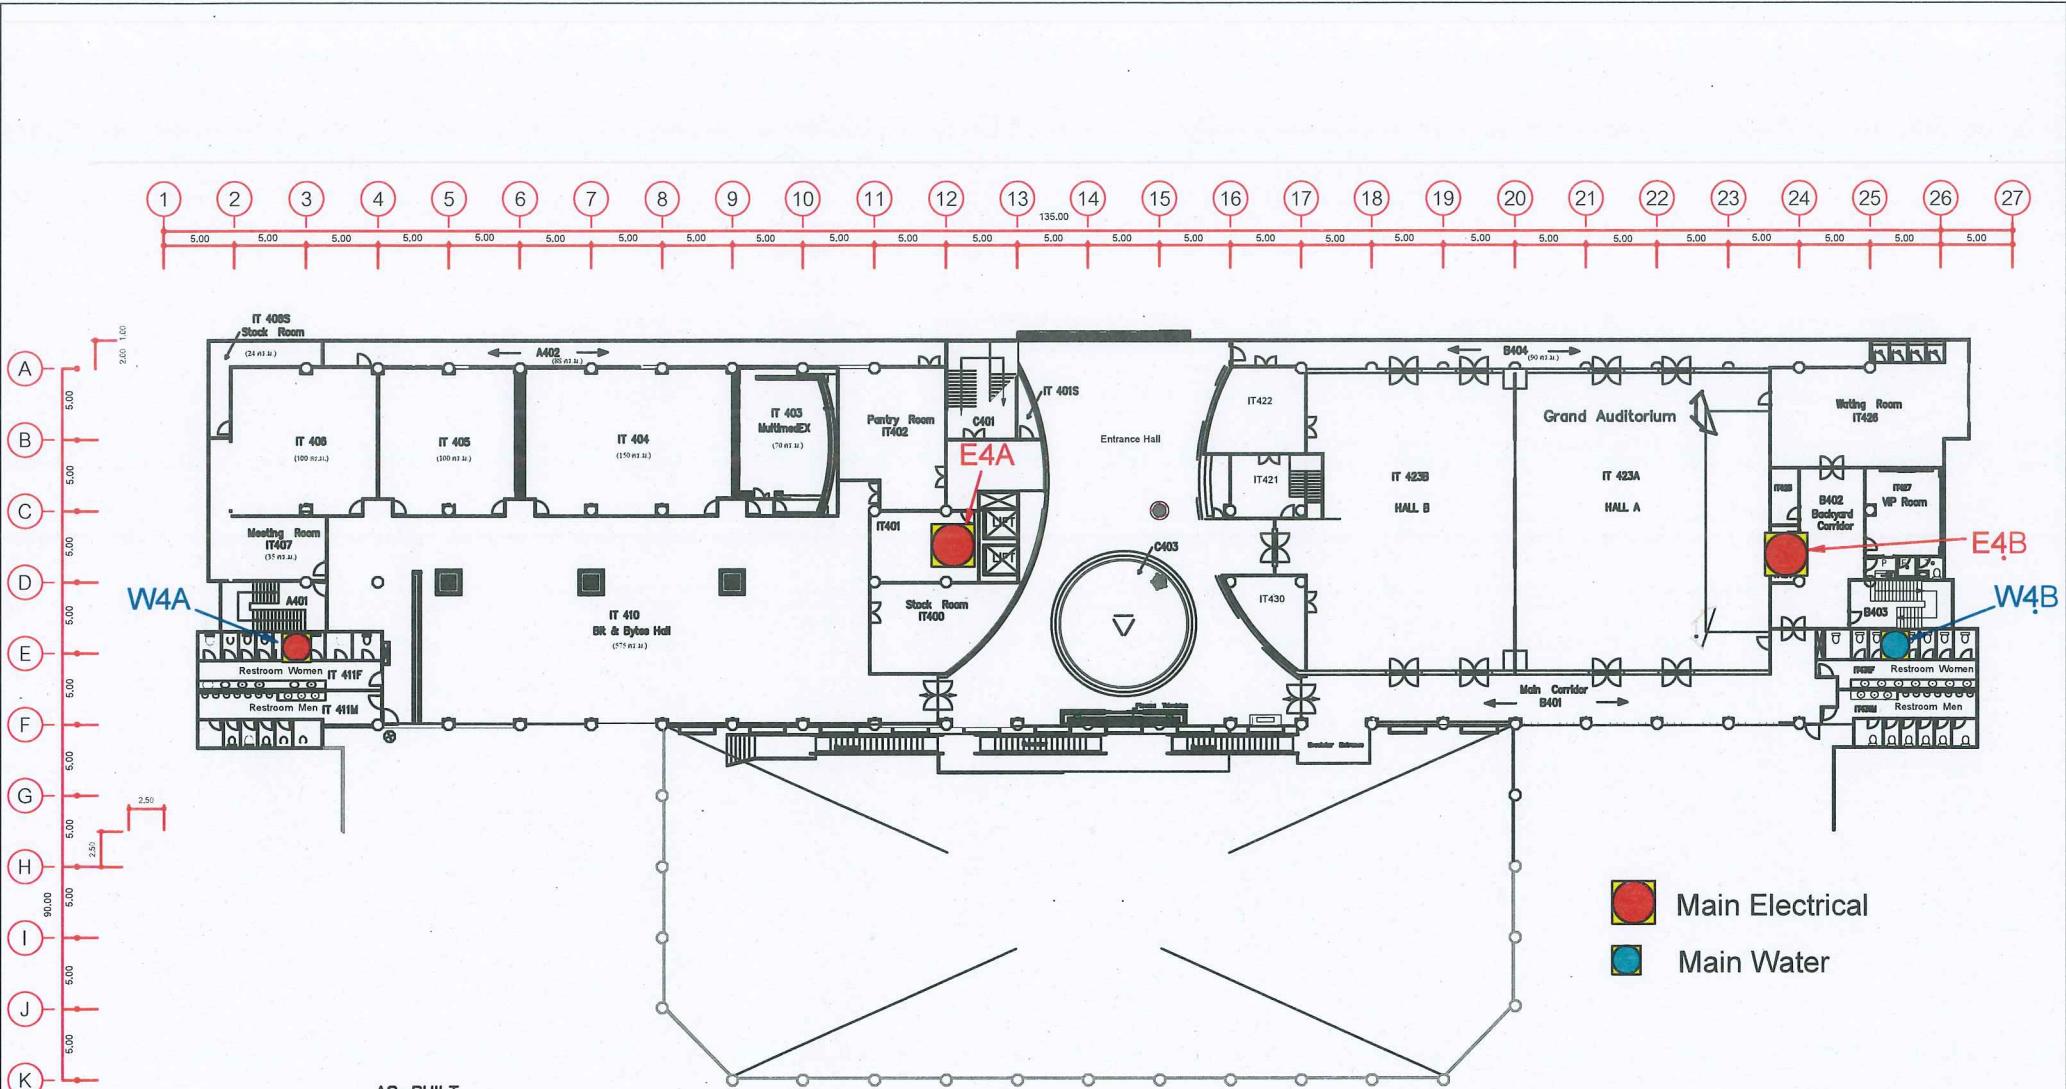

AS-BUILT.
LAYOUT PLANT
FOR 4 TH FLOOR ICT BUILDING

FLOOR 4

- Main Electrical
- Main Water

Information and communication Technology		Faculty, Mahidol University	Title of project	PROPOSE INTERIOR DESIGN & RENOVATION TO ICT CENTER MAHIDOL UNIVERSITY	Name of drawing	AS-BUILT LAYOUT PLANT FOR 4th FLOOR	Scale	1:10	ENGINEER	Y. Jeansamot Engineer of ICT	Date of revision	Update: 24/10/2018	No.	4
--	--	-----------------------------	------------------	---	-----------------	-------------------------------------	-------	------	----------	---------------------------------	------------------	--------------------	-----	---



